



PROPOSED ELEVATED PLATFORM FOR WIRELESS CARRIERS

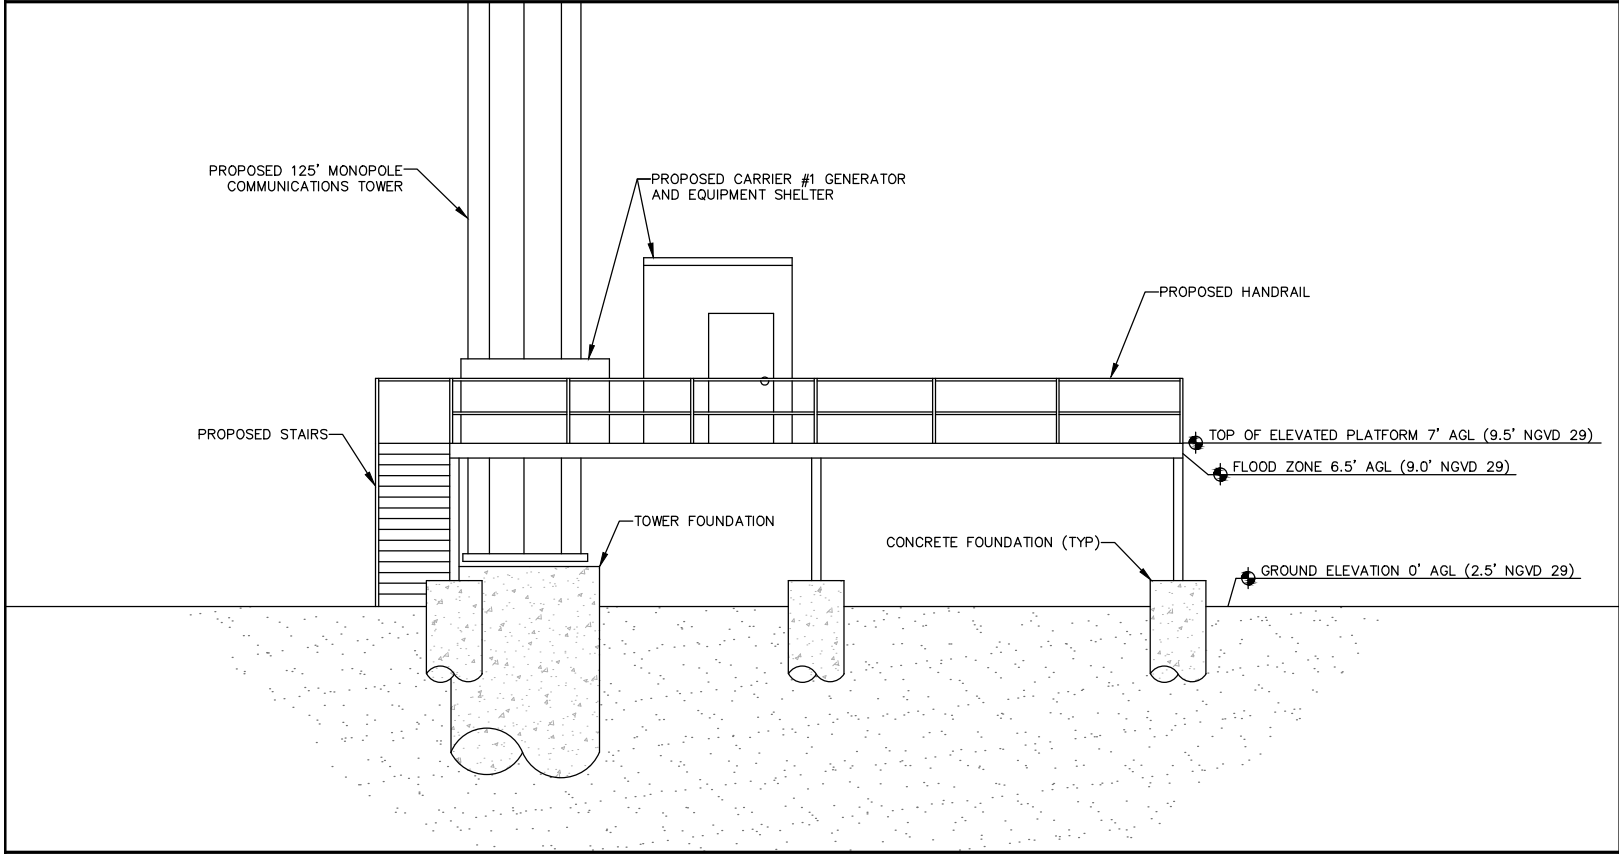


PROPOSED ELEVATED PLATFORM FOR WIRELESS CARRIERS

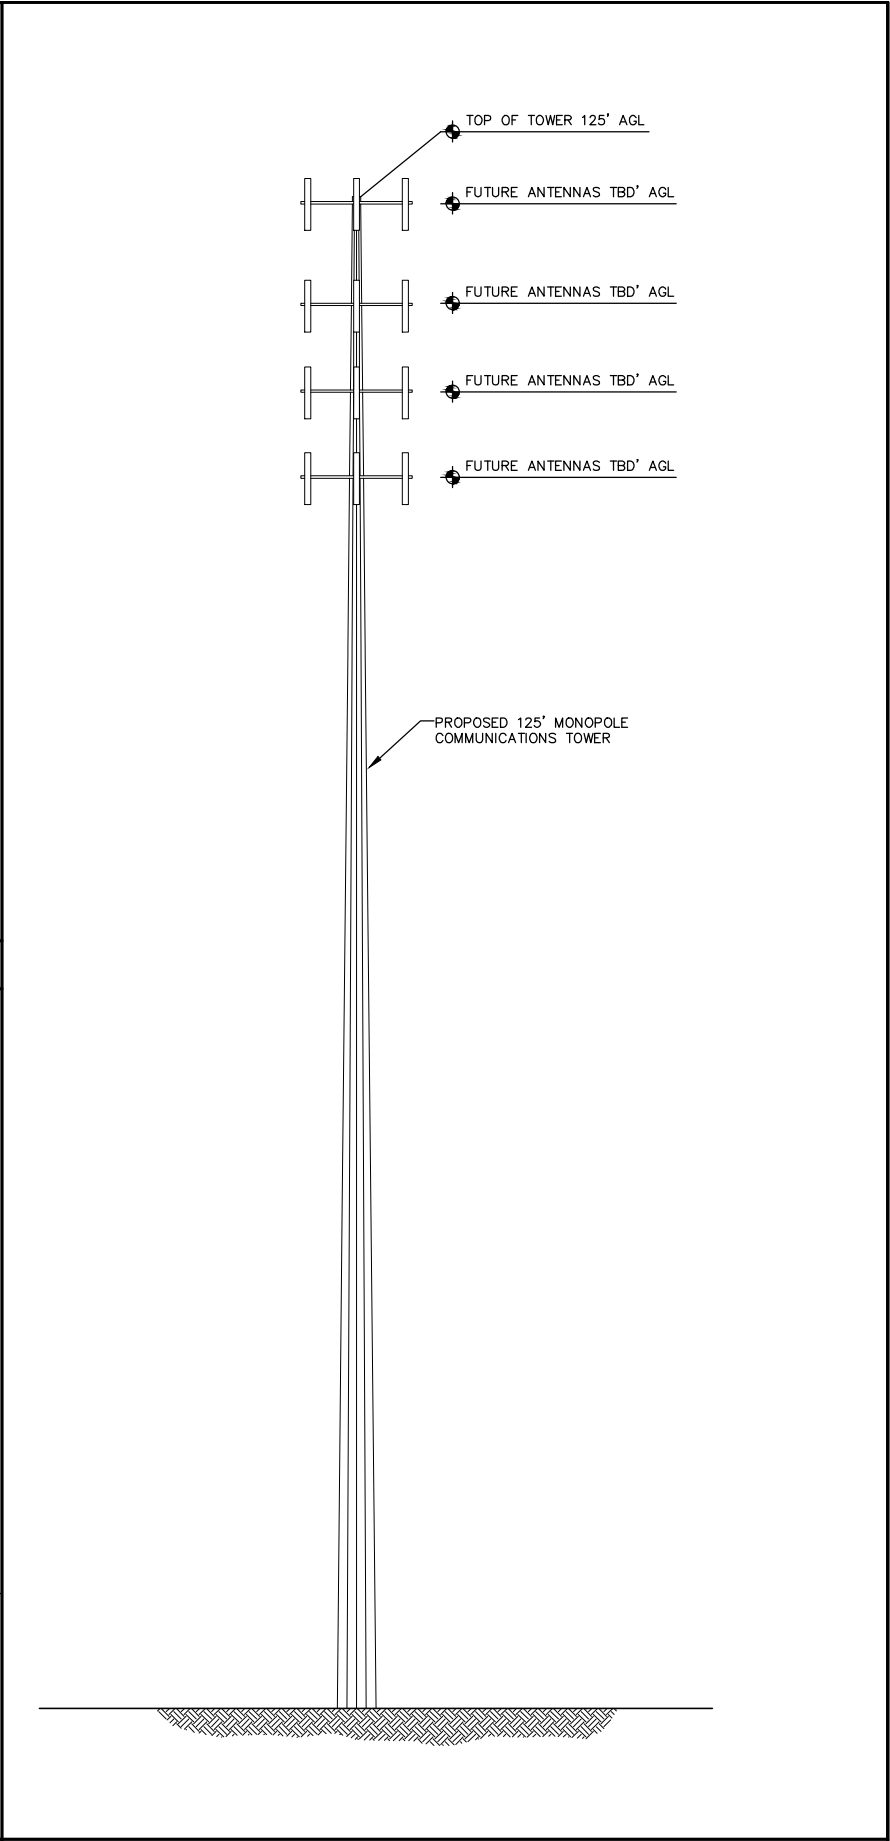

PROPOSED TOWER ELEVATION

PROPOSED SITE PLAN-KEYS WEST TELCO-AMERICAN LEGION POST #28, 5610 COLLEGE ROAD, KEY WEST, FL

APPLICANT/OWNER:




KEY WEST
TELCO, LLC

P.O. BOX 999
TAVERNIER, FL 33070
305-852-8171

PROJECT NAME AND LOCATION:

AMERICAN LEGION POST 28
5610 COLLEGE ROAD
KEY WEST, FLORIDA 33040

PROJECT ENGINEER



WAYPOINT

ENGINEERING AND EQUIPMENT LLC
820 W. INDIANTOWN ROAD, SUITE 105
JUPITER, FLORIDA 33458
PHONE: 561-252-1220
FLORIDA CA#29673

ENGINEER SEAL

RUSSELL C. MORRISON, P.E.
FLORIDA P.E. #51567

DATE OF ISSUE

OCTOBER 4, 2018

ISSUED FOR

ZONING DOCUMENT

SUBMITTALS

REV.	DATE	DESCRIPTION

PROJECT NUMBER

L201805-06

DRAWN BY	CHECKED	APPROVED
RCM	RCM	RCM

APPROVING AGENCY

KEY WEST, FLORIDA

BUILDING CODE

2017 FLORIDA BUILDING CODE

SHEET TITLE

SITE PLAN

SHEET NUMBER

Z-2